


ADDENDUM NO. 4

PUBLIC STAIRWAY **CONSTRUCTION PHASE**

BID #26-011
PAWTUCKET, RI

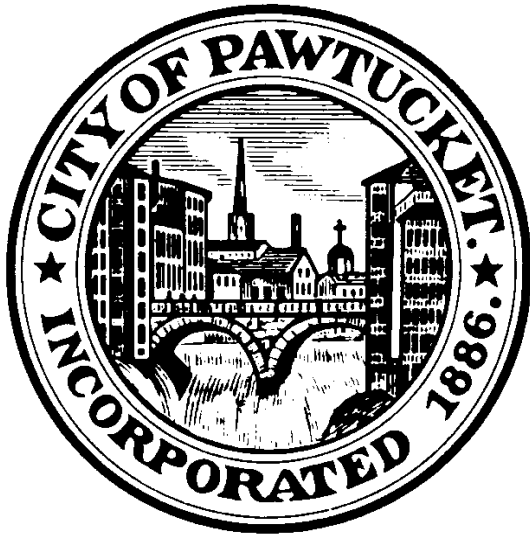

PAWTUCKET, RHODE ISLAND

DEPARTMENT OF PUBLIC WORKS
250 ARMISTICE BOULEVARD
PAWTUCKET, RHODE ISLAND

ISSUED: June 26, 2026

Addendum #4 – June 26, 2026

PUBLIC STAIRWAY CONSTRUCTION PHASE BID #26-011 Pawtucket, RI

The attention of bidders submitting proposals for the above-referenced project is called to the following Addendum to the Request for Proposals indicated above. The items set forth herein, whether of omission, addition, substitution or other change, are all to be included in, and form a part of the proposed Contract Documents for the work.

Inclusion of this Addendum must be acknowledged in the spaces provided in the document entitled "Request for Proposals Bid #26-011; Public Stairway Construction Phase". Failure to acknowledge any and all addenda in the above specified bid form may be cause for rejection of the bids by the Owner on the grounds that it is not responsive.

This Addendum consists of one (1) page and one (1) attachment, (3 pages) for a total of four (4) pages.

1. UPDATES TO REQUEST FOR PROPOSALS

a. None Issued

2. Clarifications

Ref. Plan Sheet 30; RIDOT standard detail 18.4.2 on Lighting Detail Sheet No. 3 refers to standard electrical enclosure heater with thermostat for the enclosure.

Ref. Plan Sheet 31: Riser Pole conduit shall be per detail on Lighting Detail Sheet No. 3, consisting of one (1) Rigid Galvanized Steel Conduit.

Ref. Technical Specifications: Section 16560-4, Part 2, Products, 2.5 Conduits and Fittings, sub-section F, Conduit Sweeps shall be interpreted as: All Conduit types, for all conduit applications and all conduit sizes, shall be set 2'-6" below grade.

ATTACHMENTS:

A. Supplemental Details and Plans


a. Plan Sheets 29 and 31

Please contact Michael Wilcox (401-728-0500 ext. 447), City of Pawtucket, with any questions.


Attachment A: Supplemental Details and Plans

LIGHT FIXTURE SCHEDULE						
TYPE	DESCRIPTION	MANUFACTURER	MODEL NO.	LAMPS	MOUNTING	NOTES
1/EA	12' POLE LIGHT	LUMEC	DOS 24W16LED 4K G3 LE3F UNV DMG YM BKTX	24W LED	POLE	SEE NOTE 1
2/EB	LIGHT COLUMNS	TPOLOGY RING LIGHT	CQ754-Q2 SIL	LED	POLE	SEE NOTE 2
3/EC	SHEPARD'S CROOK LIGHT	LUMEC	DOS 55W16LED 4K G3 LE3F UNV DMG YM BKTX	55W LED	POLE	SEE NOTE 3

NOTE 1: PROVIDE 12' POLE, BRACKET ARM #DOS-DBA
NOTE 2: PROVIDE (3) LIGHT RINGS WITH 20' POLE
NOTE 3: PROVIDE 14' POLE, BRACKET ARM #DOS-DBA, AND PROVIDE GFI DUPLEX RECEPTACLE
NOTE 4: LIGHT TYPE 1/EA AND 3/EC SHALL MATCH THE OWNER SELECTION FOR THE CITY OF PAWTUCKET 26-012 RIVERWALK WEST PROJECT.

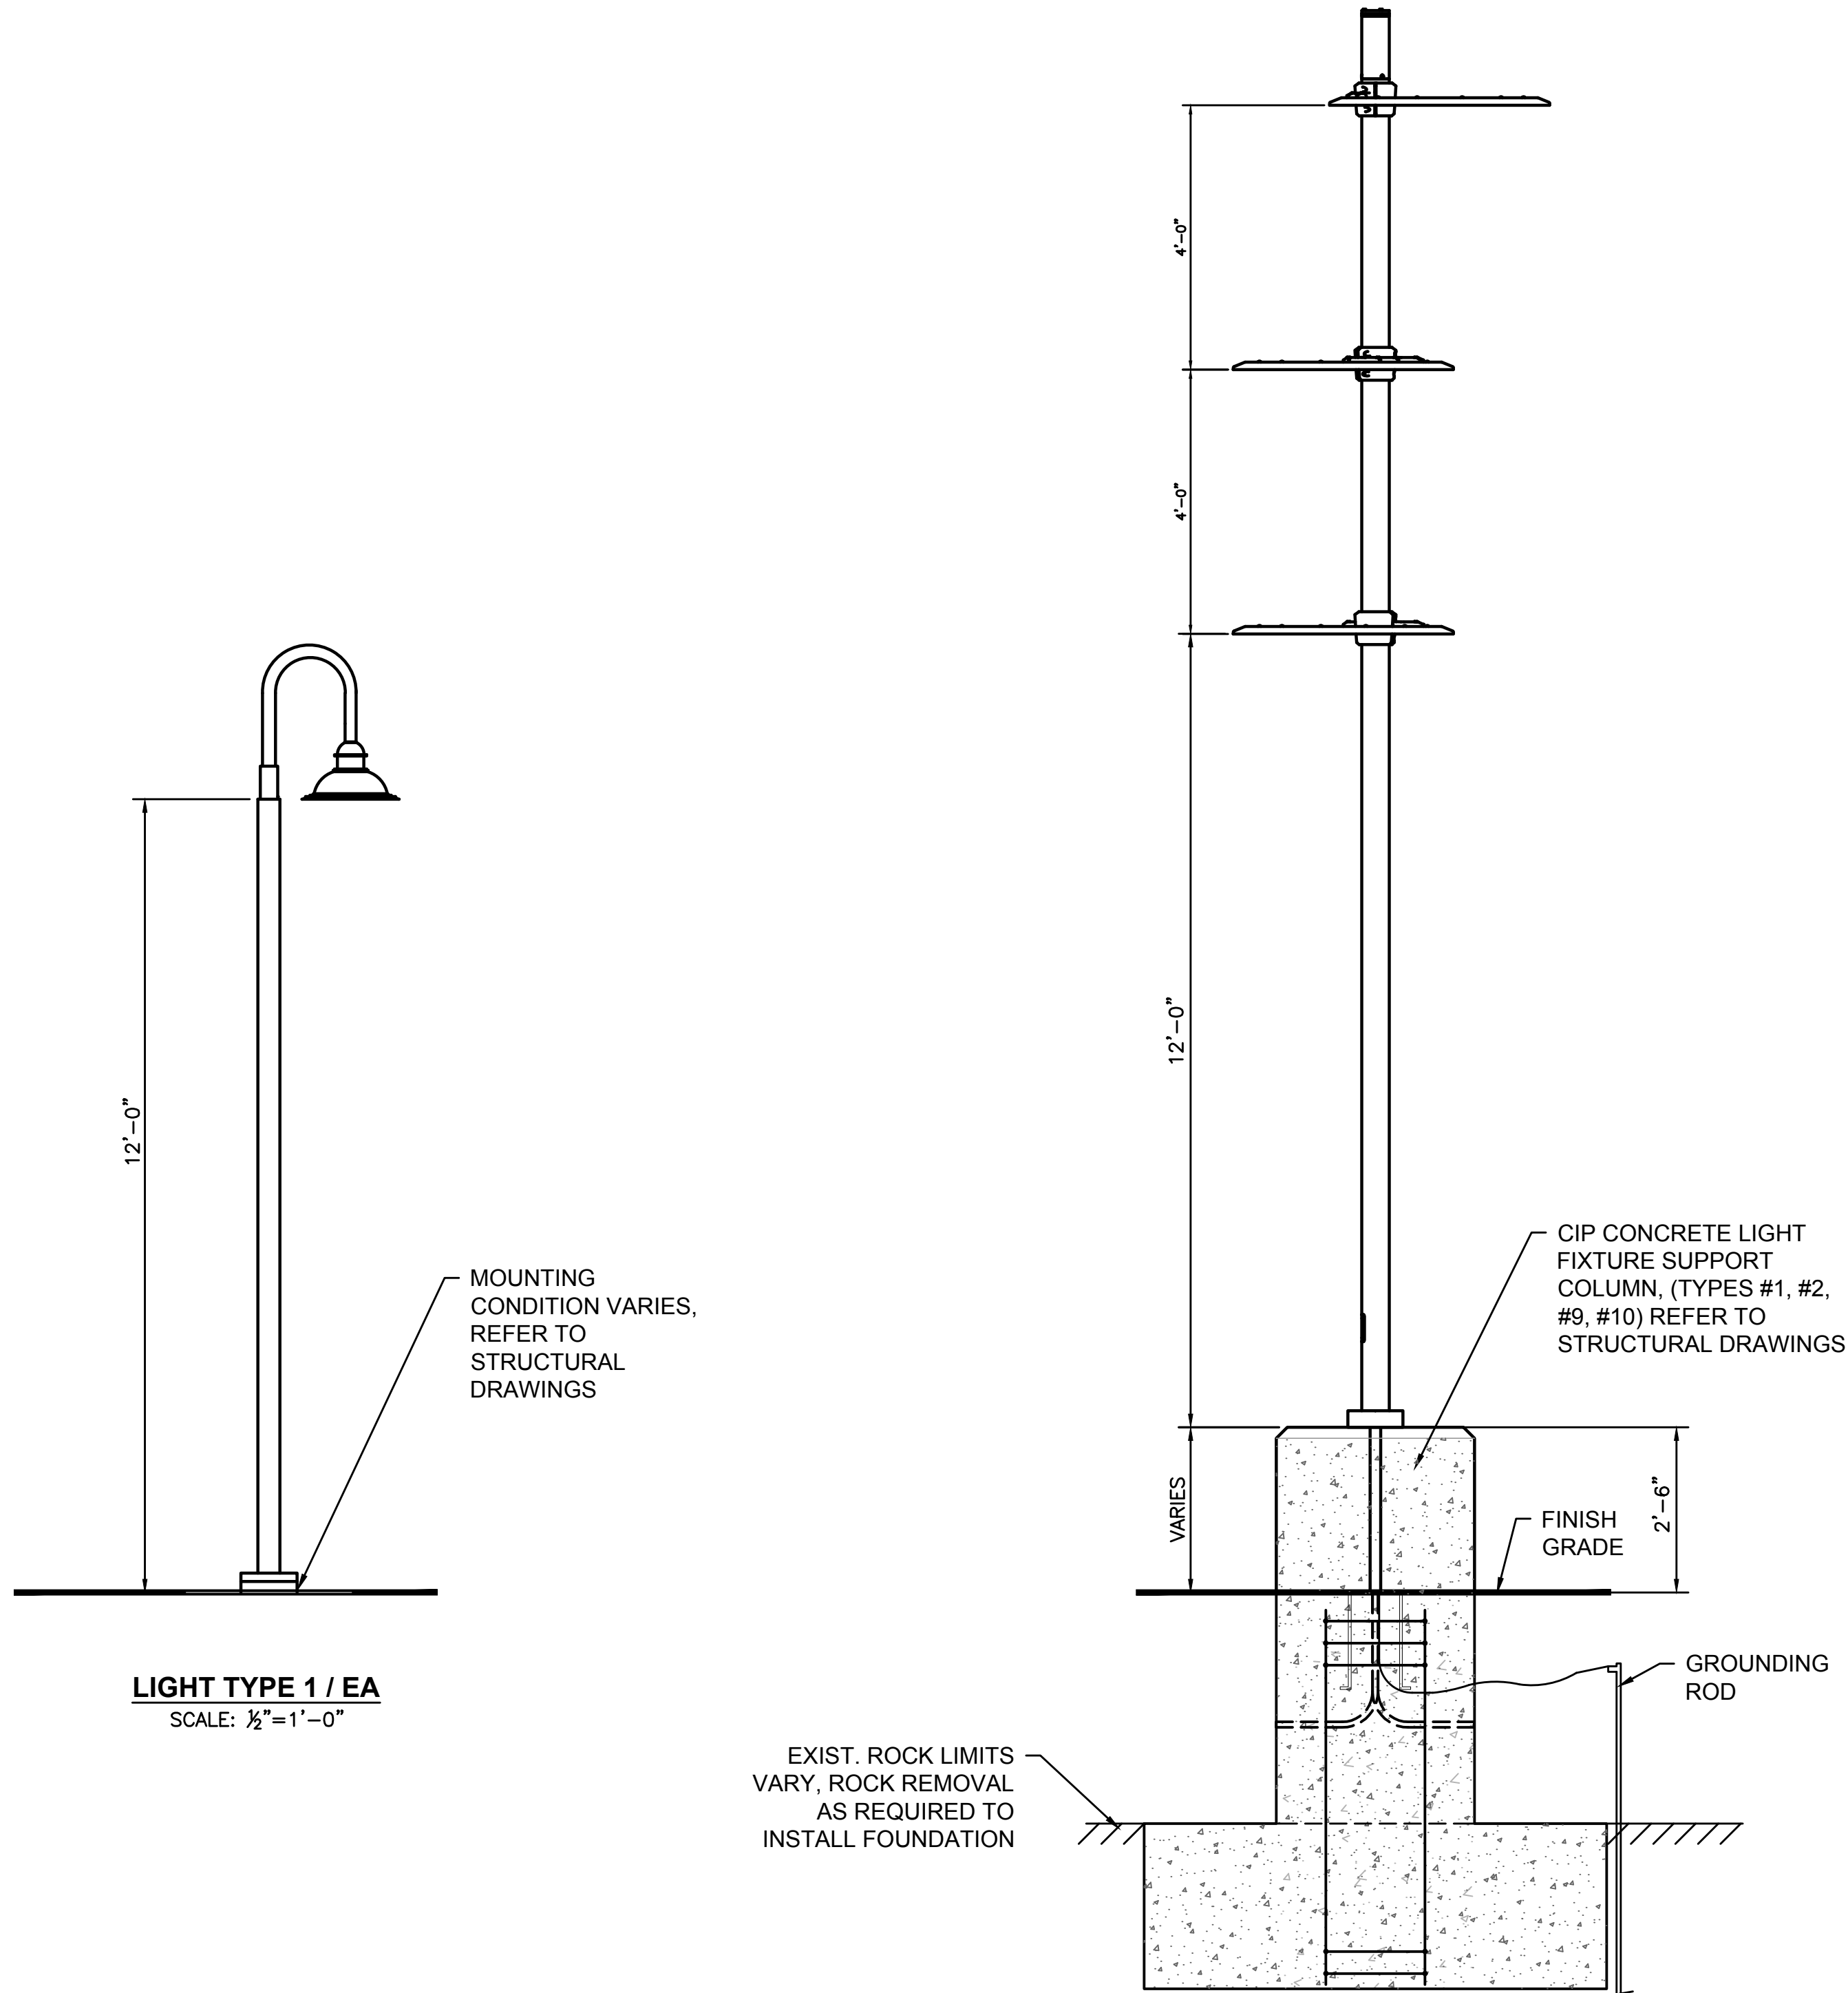

LIGHT TYPE 2 / EB
SCALE: 1/2"=1'-0"

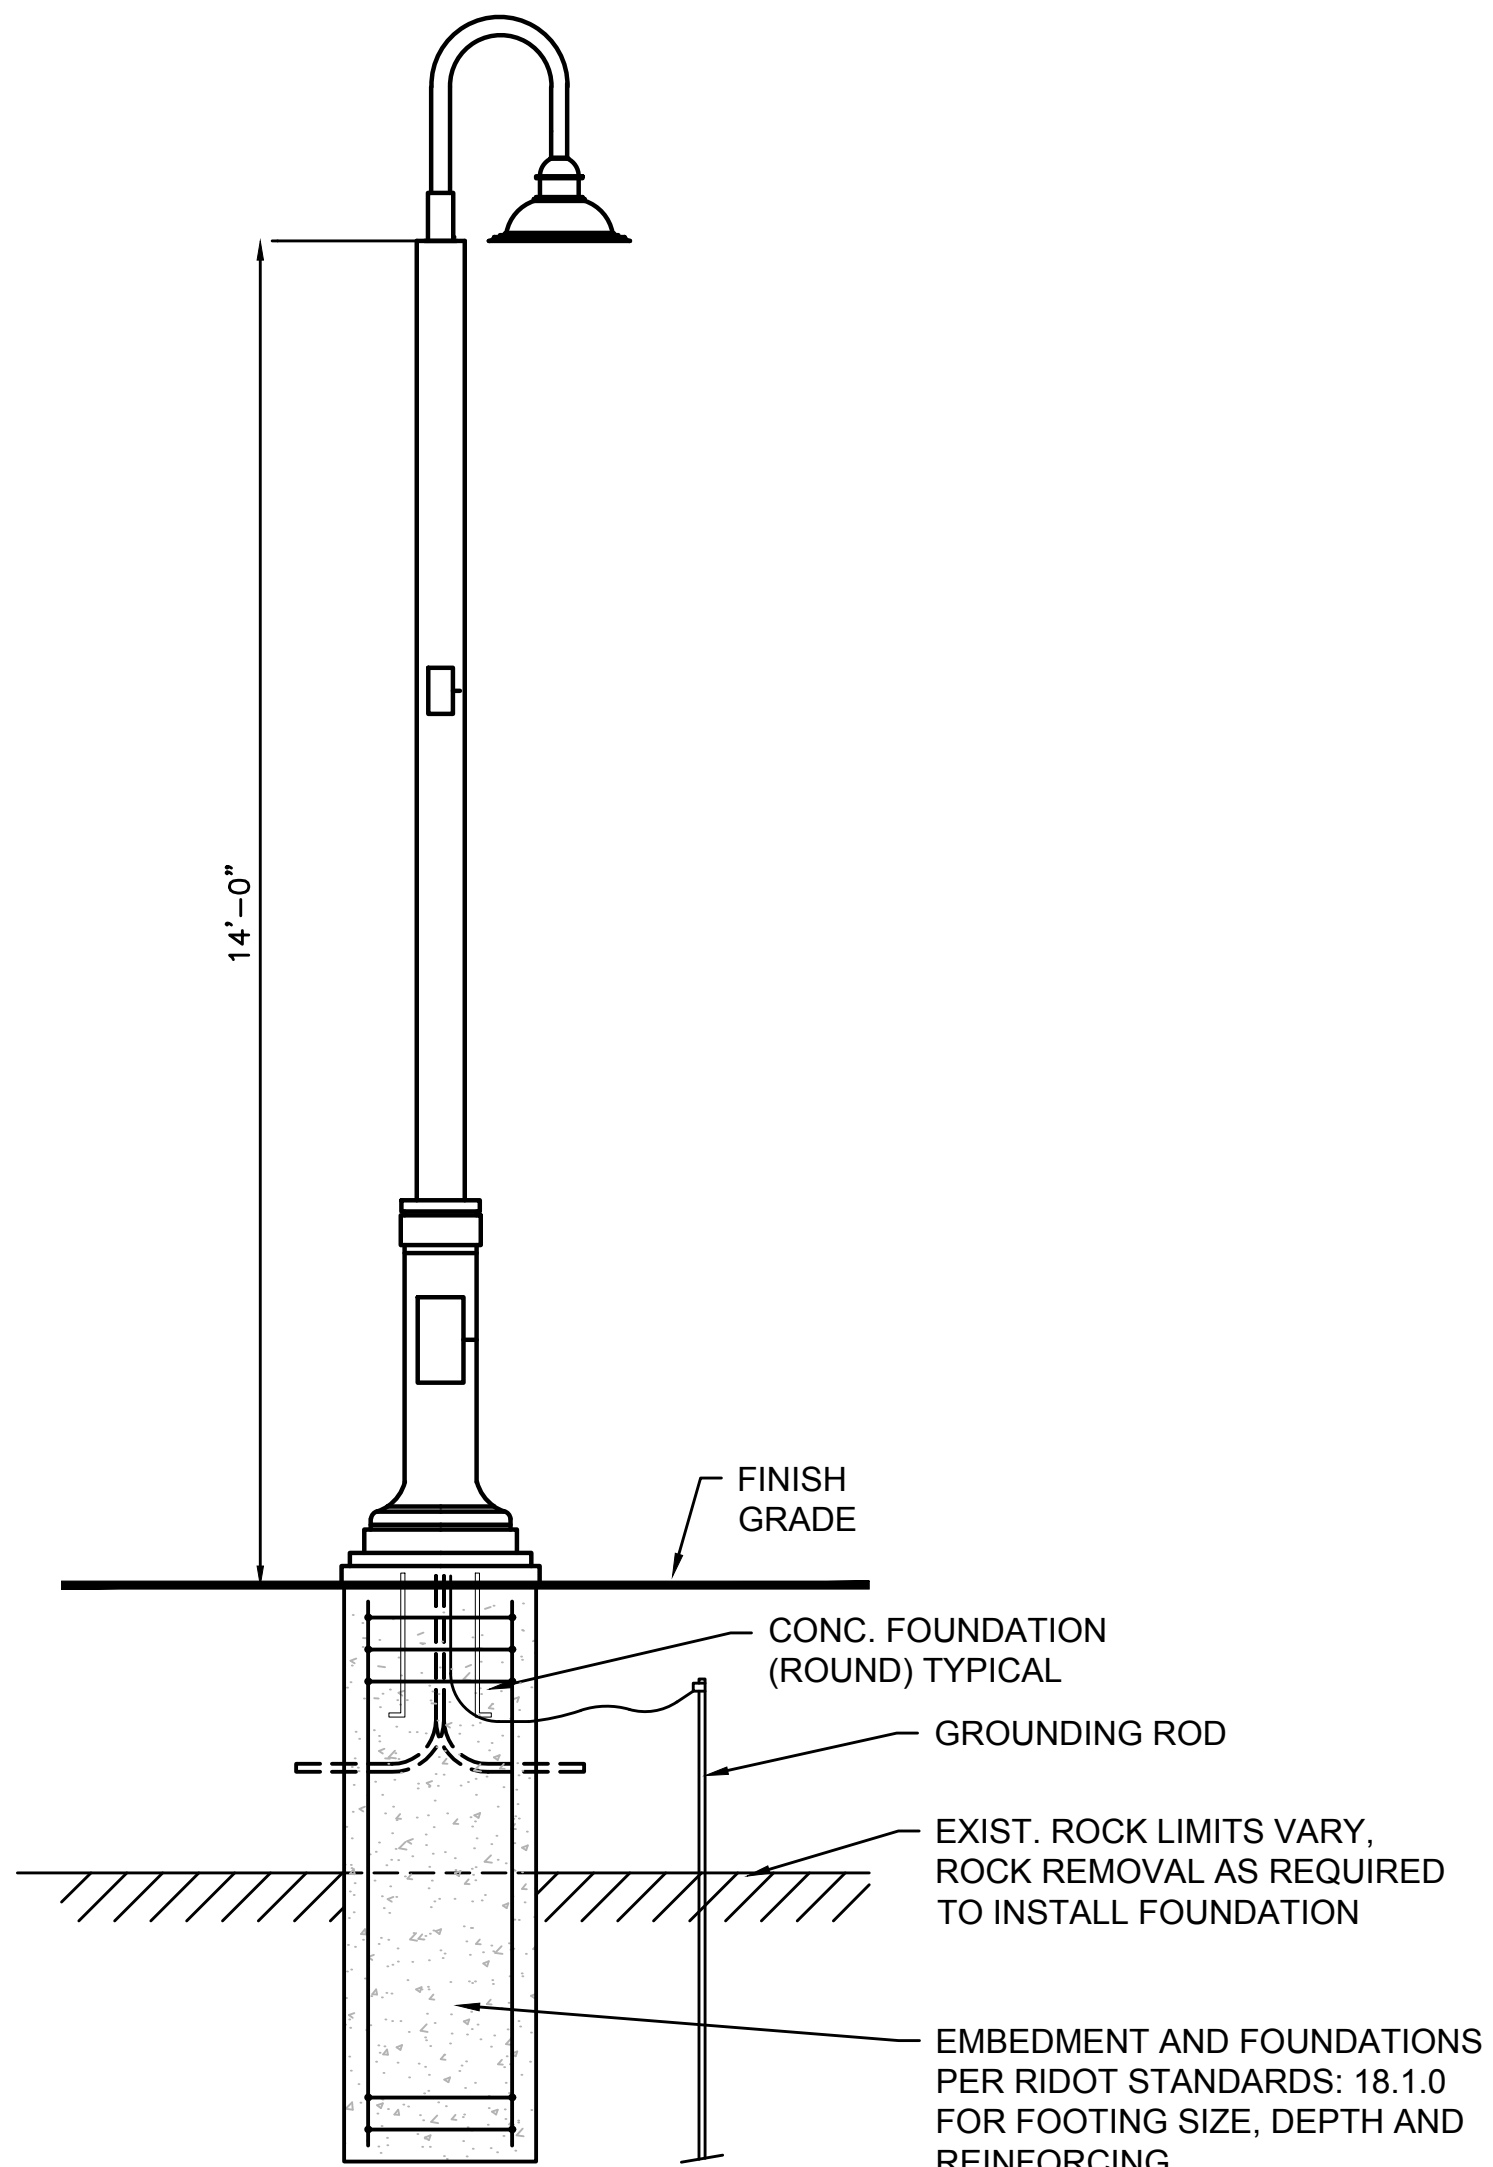

LIGHT TYPE 3 / EC
SCALE: 1/2"=1'-0"



ADDENDUM NO. 4, REVISION 2

PREPARED BY



REGISTERED PROFESSIONAL



SUBCONSULTANT

PROJECT

Pleasant Street Public Stairway Construction Phase

Bid No. 26-011

Pawtucket, RI

TITLE

ELECTRICAL DETAILS - LIGHT FIXTURE TYPES

	LIGHT FIXTURE SCHEDULE	6/26/2016
	FOOTING DIMENSIONS	6/16/2016
	REVISIONS	DATE

DRAWN BY: AD

DESIGNED BY

CHECKED BY: KA

ISSUE DATE: 5/13/2026

BETA JOB NO.: 11433

SCALE

AS SHOWN

UNLESS OTHERWISE NOTED OR CHANGED BY REPRODUCTION

ADDENDUM NO. 4

SHEET NO

29




NOT TO SCALE

ADDENDUM NO. 4, REVISION 1

BETA

www.BETA-Inc.com

REGISTERED PROFESSIONAL

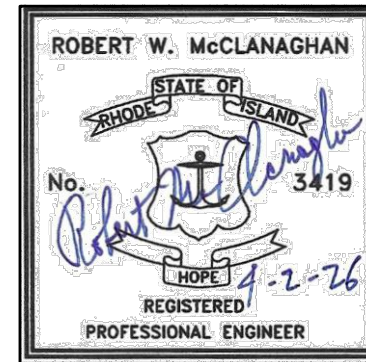

SUBCONSULTANT

MC²
MCCLANAGHAN
ASSOCIATES, INC.
ELECTRICAL ENGINEERS

178 TREASURE ROAD, NARRAGANSETT, RI 02882
T: 401-524-3457
RWM@RWMENGINEERING.COM

PROJECT

Pleasant Street Public Stairway Construction Phase

Bid No. 26-011

Pawtucket, RI

TITLE

LIGHTING DETAILS NO. 3

1	ONE-LINE UPDATE	6/26/26
NO.	REVISIONS	DATE

DRAWN BY:

DESIGNED BY: RWM

CHECKED BY:

ISSUE DATE: 5/13/2026

BETA JOB NO.: 11433

SCALE



UNLESS OTHERWISE NOTED OR CHANGED BY REPRODUCTION

ADDENDUM NO. 4

SHEET NO.

31